

Inspiration at Southpoint

Ft Meyers FL


Sales Contact:

Trevor Hayes

Date: 09-15-21

Version: 1.01

Scale: 9/64"=1'-0"

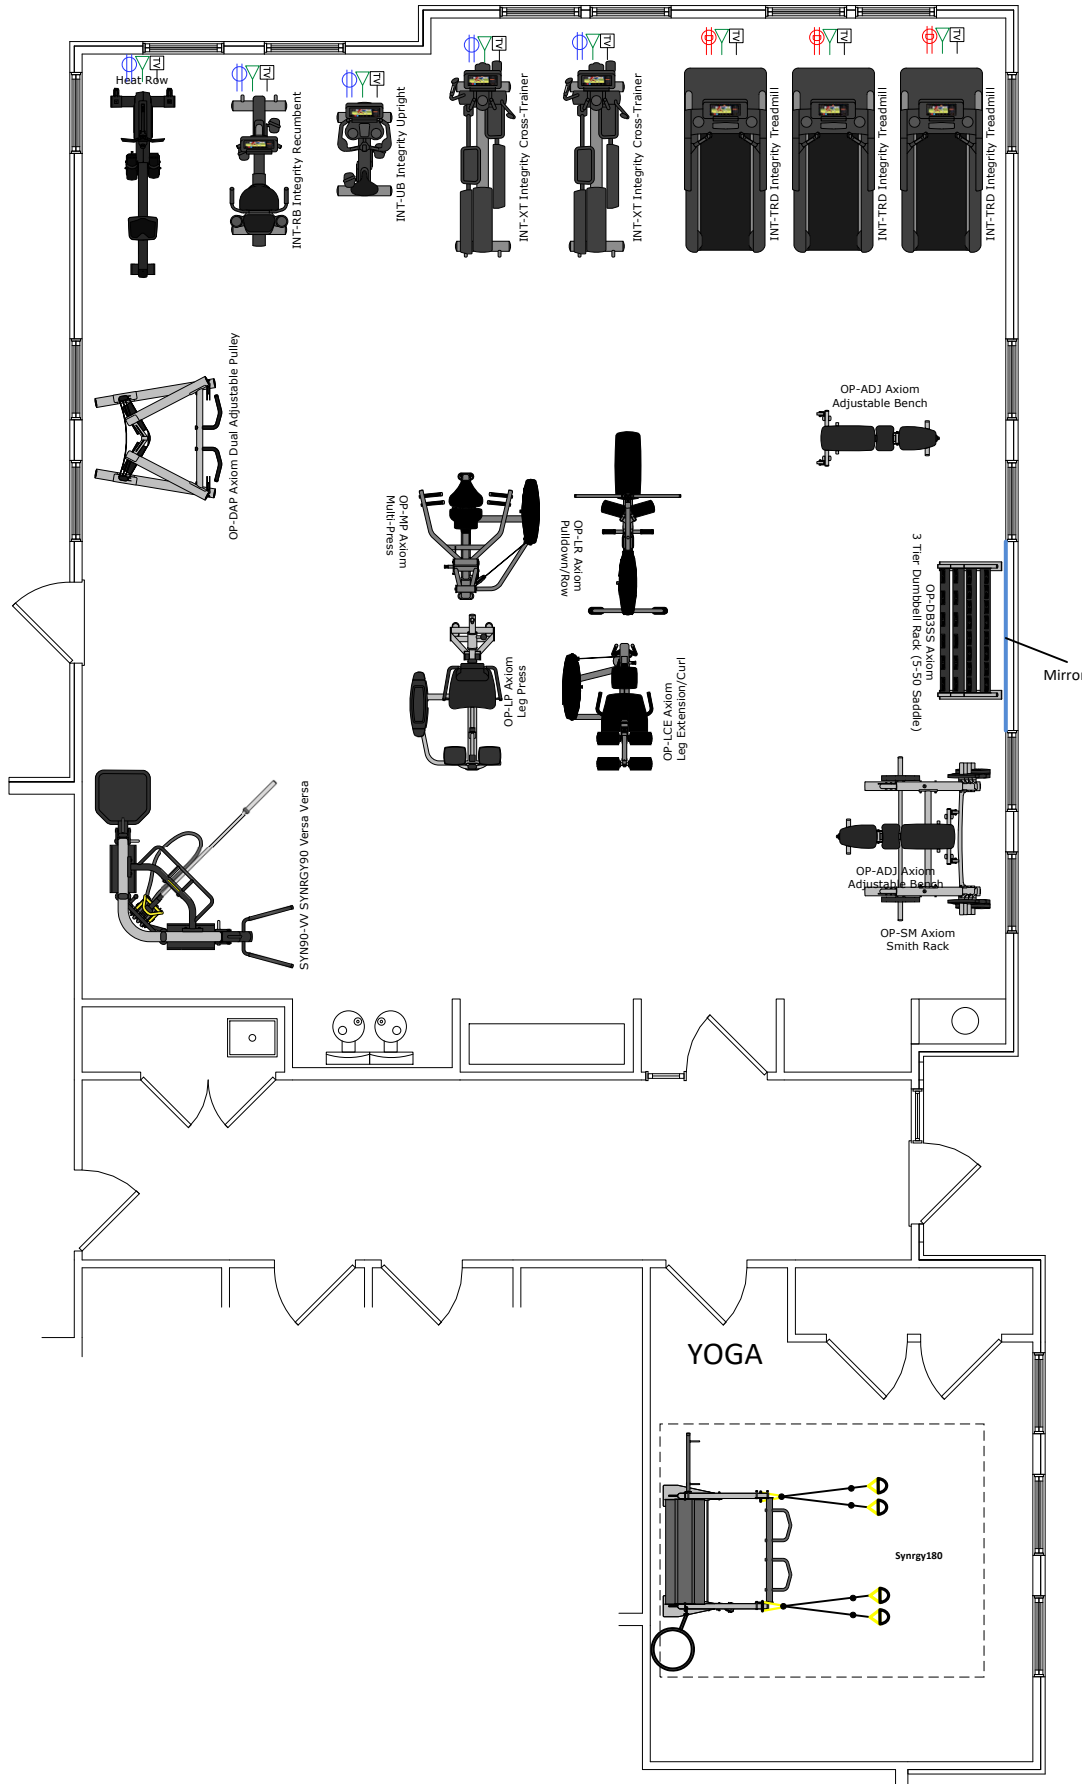

DISCLAIMER:
THIS FLOORPLAN IS PROVIDED FOR GENERAL VISUAL REFERENCE ONLY. ANY DIMENSIONS USED TO CREATE THESE DRAWINGS SHOULD BE VERIFIED BY THE OWNERS OF THE FACILITY, CONTRACTORS AND/OR THEIR AGENTS. THESE DRAWINGS ARE NOT DESIGNED TO BUILD FROM AND SHALL NOT BE USED AS BUILDING DOCUMENTS BY ANY PARTIES. LIFE FITNESS MAKES NO REPRESENTATION OR WARRANTY THAT THE FLOORPLAN COMPLIES WITH ANY APPLICABLE LAW, CODES, RULE OR REGULATION OR ANY INDUSTRY OR SAFETY STANDARD OR REQUIREMENT, INCLUDING ASTM OR EUROPEAN STANDARD SPACING RECOMMENDATIONS FOR ACCESS, PASSAGE AROUND, OR EMERGENCY DISMOUNT. COMPLIANCE WITH INDUSTRY STANDARDS, APPLICABLE LAW, CODES, RULE OR REGULATION REGARDING PLACEMENT OF AND CLEARANCE OF EQUIPMENT AND ASSOCIATED ITEMS IS BY OWNER AND LIFE FITNESS DISCLAIMS ALL RESPONSIBILITY WITH RESPECT THERETO.

ADDITIONAL NOTES:
FLOOR PLAN DIMENSIONS ARE BASED ON INFORMATION PROVIDED BY FACILITY OWNER OR ITS REPRESENTATIVES AND SHOULD BE VERIFIED IN THE FIELD.

Electrical Legend:

- STANDARD RECEPTACLE
- DEDICATED RECEPTACLE
- WIFI / WIRED INTERNET
- TV CONNECTION

CONSULT A QUALIFIED ELECTRICAL PROFESSIONAL TO DETERMINE POWER REQUIREMENTS AND PLACEMENT.

POWER, DATA, AND TV REQUIREMENTS VARY BASED ON OPTIONS SELECTED.

